 

 
 


 

 

 
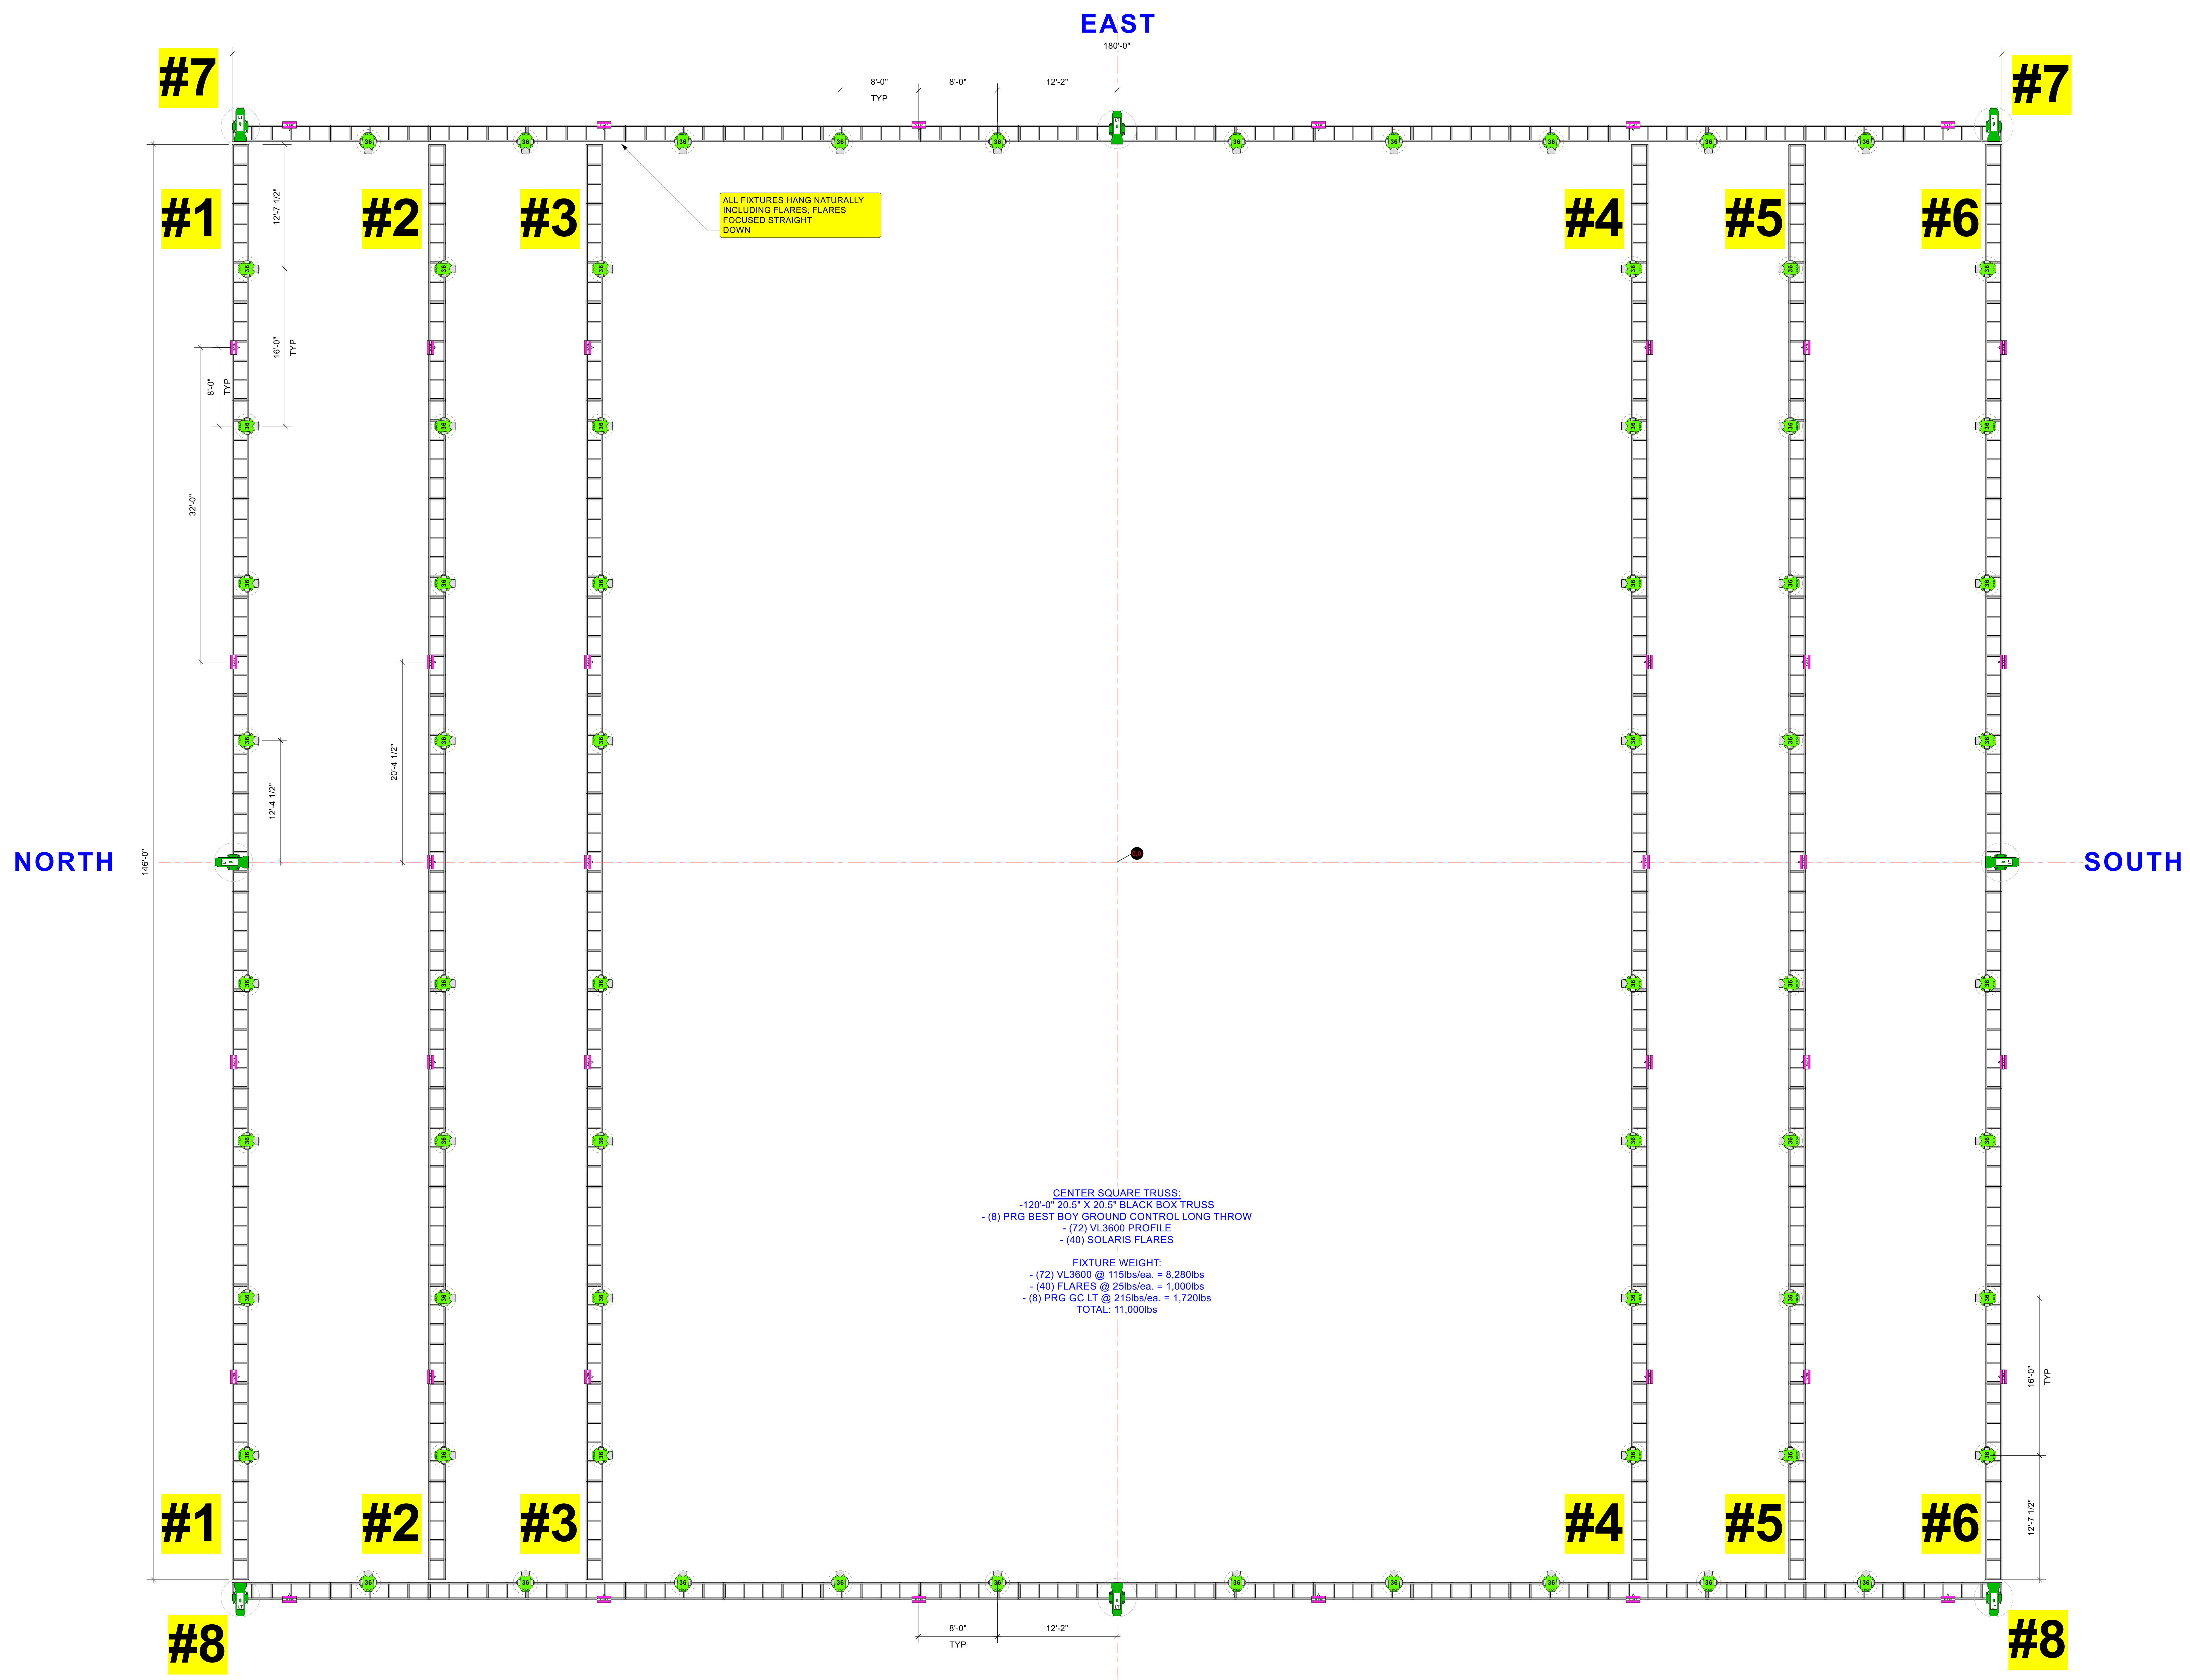


This document is the property of Entertainment Design Group, Inc. and is to be used only for the project and location specified. It is not to be reproduced, stored in a retrieval system, or transmitted in any form or by any means, electronic, mechanical, photocopying, recording, or by any information storage and retrieval system, without the prior written consent of Entertainment Design Group, Inc. The user assumes full responsibility for any errors or omissions in this document. The user agrees to hold Entertainment Design Group, Inc. harmless for any damages, including consequential damages, arising from the use of this document. The user agrees to indemnify and hold Entertainment Design Group, Inc. harmless for any damages, including consequential damages, arising from the use of this document.

**INSTRUMENT KEY**

-  TMB Solaris Flare @ 1kw
-  ACME Outline 360 @ 450 w
-  Ayrton Diablo @ 550w
-  ETC Zoo
-  Protobus Radius
-  Philips Var-Lite VL3600 Profile @ 1.475kw
-  Philips Var-Lite VL4000 Beamwash @ 1.4kw
-  Robe iForte LTX @ 1.25kw
-  PRG GC Longthrow @ 1.5kw
-  DF-50 Hazer @ 44w
-  RauwEX RE 5 Fan @ 2.8kw



**CENTER SQUARE TRUSS:**  
 -120'-0" 20.5" X 20.5" BLACK BOX TRUSS  
 - (8) PRG BEST BOY GROUND CONTROL LONG THROW - (72) VL3600 PROFILE  
 - (40) SOLARIS FLARES  
 FIXTURE WEIGHT:  
 - (72) VL3600 @ 119lbs/ea. = 8,280lbs  
 - (40) FLARES @ 25lbs/ea. = 1,000lbs  
 - (8) PRG GC LT @ 215lbs/ea. = 1,720lbs  
 TOTAL: 11,000lbs

1 CENTER SQUARE TRUSS  
Scale: 3/16" = 1'-0"

VENUE  
SUPERDOME  
NEW ORLEANS, LA

SHOW  
HALFTIME SHOW

LOAD IN SHOWDAY SHOW  
 TBD 02/29/25 2502  
 DESIGNER AL CURROON  
 LEAD L.D. BEN GREEN  
 GAFFER ALEN SISUL  
 PROD. 1. E. MARCHINI  
 PROD. 2. M. HUMPHREY  
 LEAD TECH R. MINNOTTE

VERSION  
 01. PRELIMINARY 11-13  
 02. FIELD TRUSS EDIT 11-24  
 03. UPDATED 11-30  
 04. UPDATED TRUSS 12-5  
 05. UPDATED TRUSS 12-26  
 06. POWER LAYOUT 1-2  
 07. CART UPDATE 1-8

PRINT ARCH E SHEET  
 SCALE AS NOTED

CONTENTS  
 01. OVERVIEW  
 02. PERIMETER TRUSS  
 03. EAST 450 RAIL  
 04. WEST 450 RAIL  
 05. CENTER TRUSS  
 06. FIELD LAYOUT  
 07. GOALPOSTS  
 08. CARTS  
 09. LAMP POSTS  
 10. N & S SECTION  
 11. E & W SECTION  
 12. FIELD POWER LAYOUT  
 13. SERVICE LEVEL POWER

SHEET #  
05

PUBLISH DATE  
01/06/2025

CENTER TRUSS