 

 
 


 

 

 
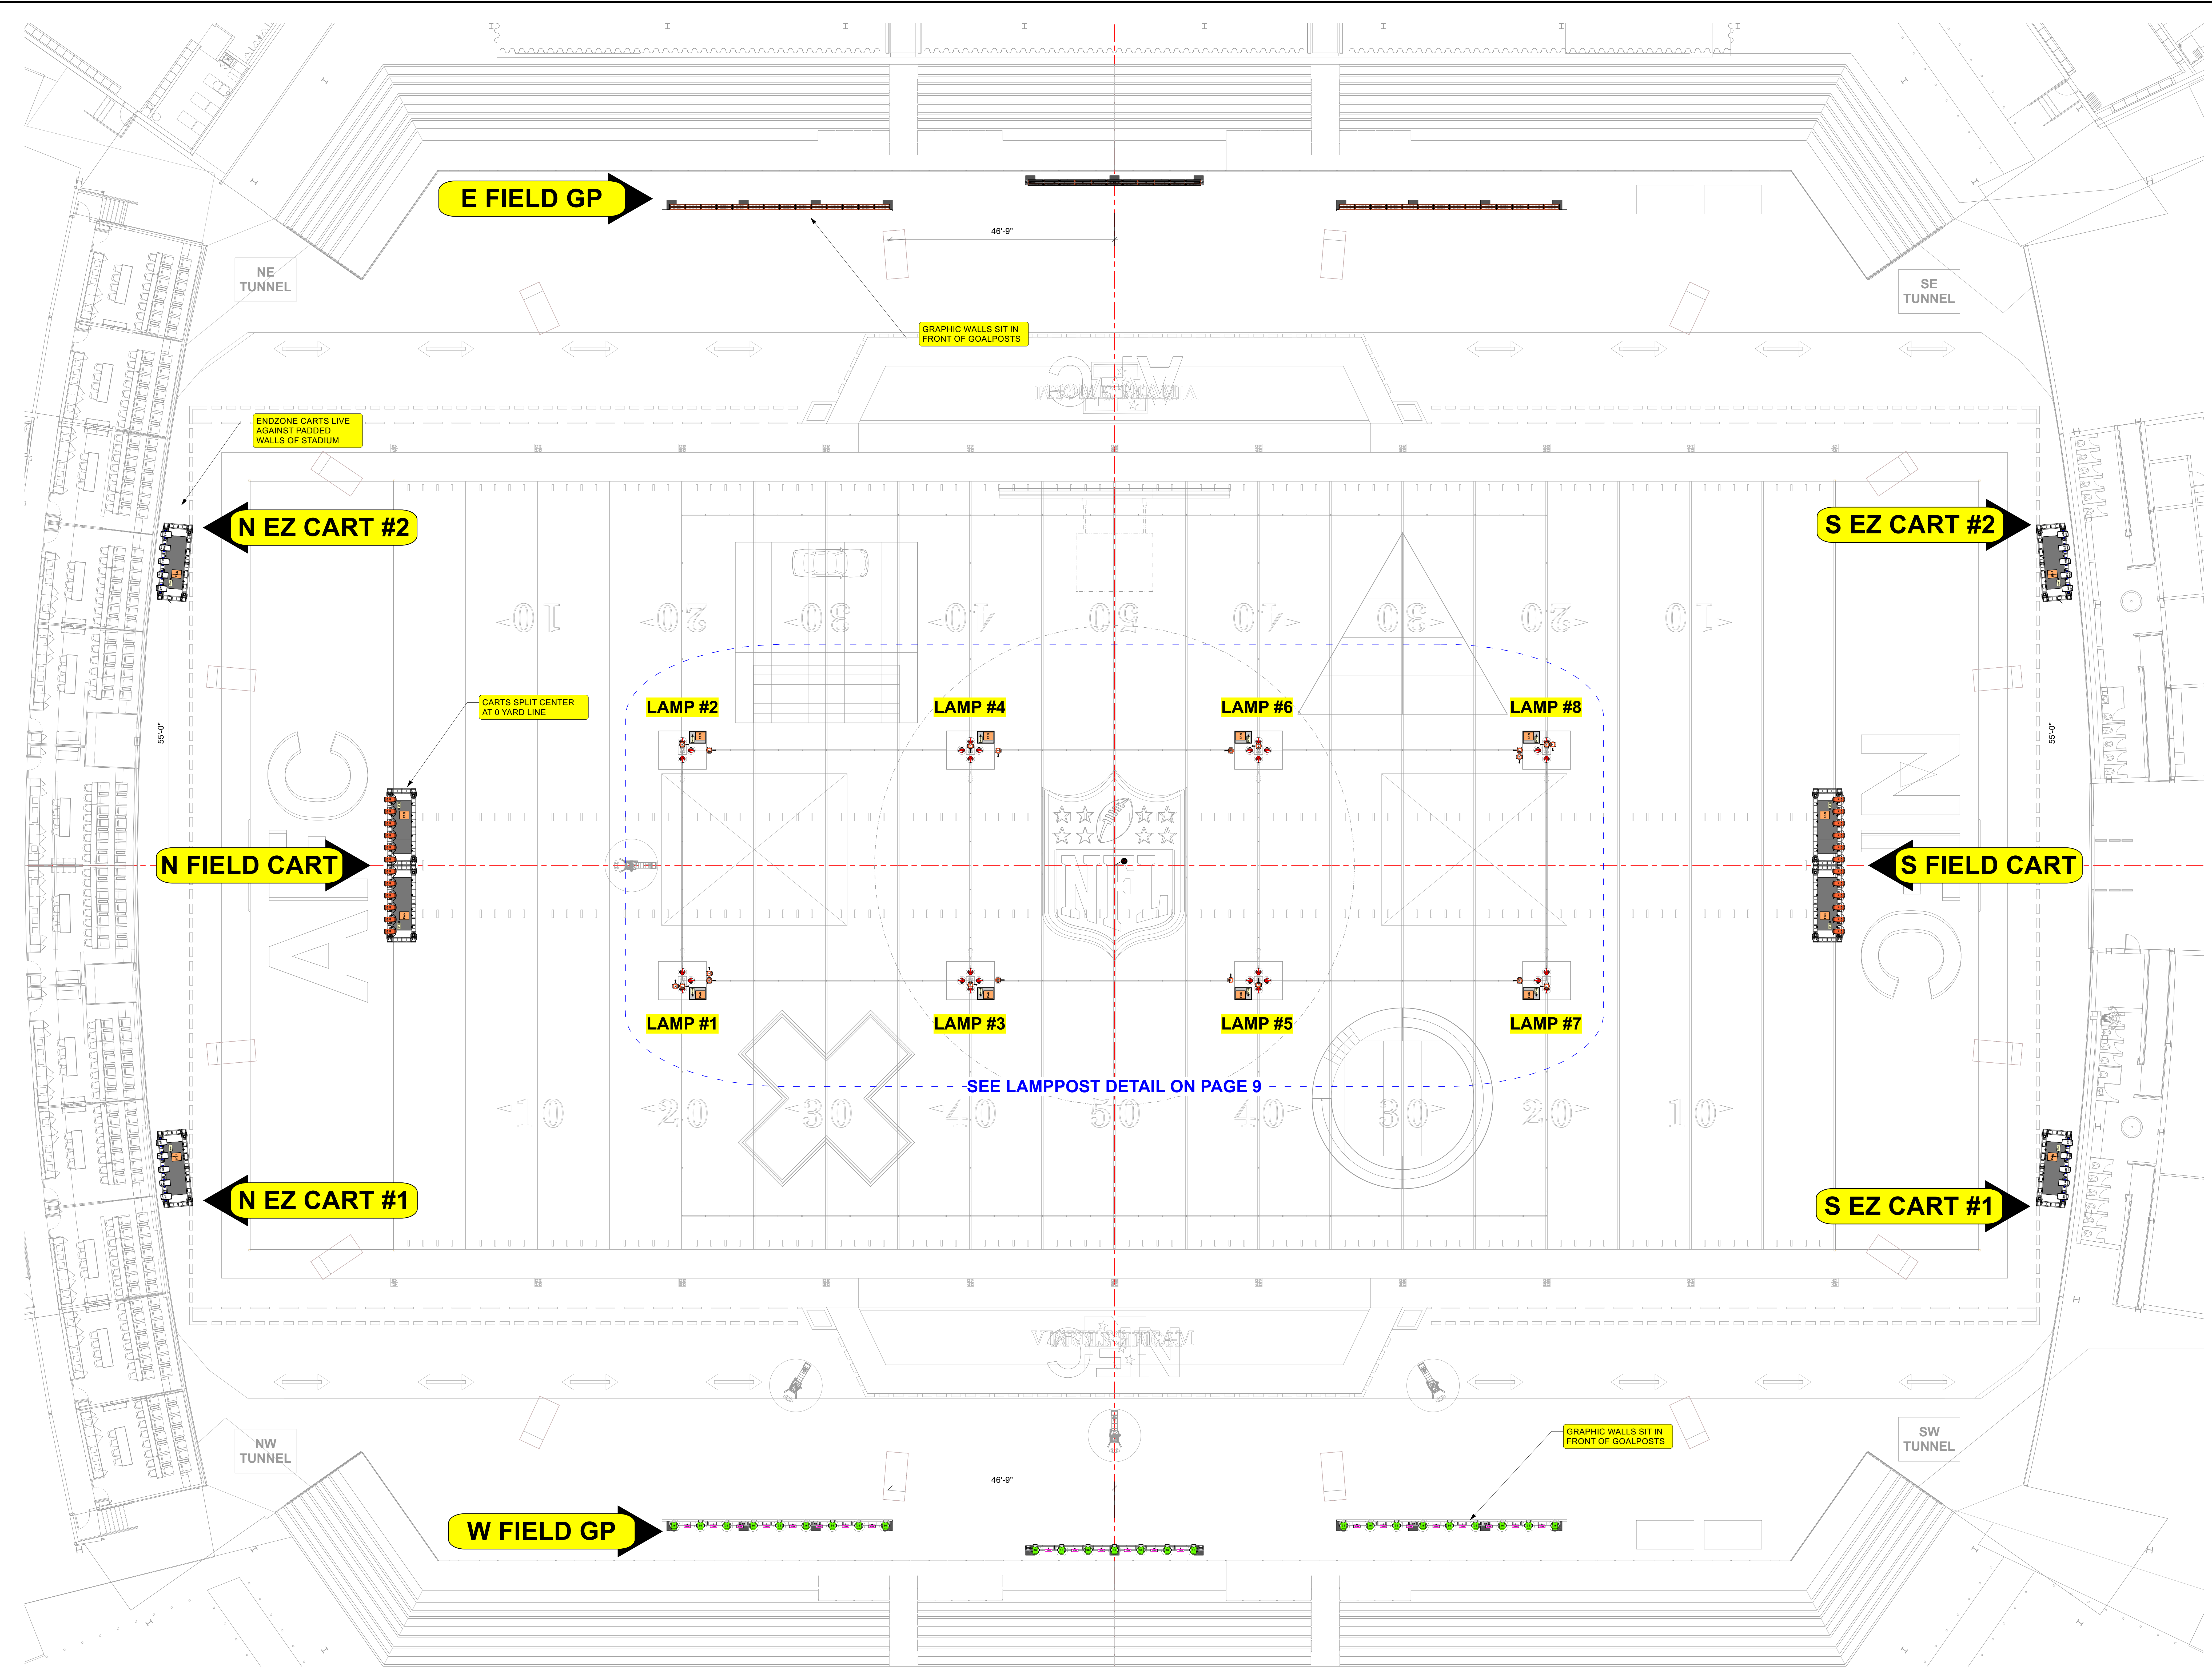


This document is the property of Entertainment Design Group, Inc. and is to be used only for the project and site for which it was prepared. It is not to be reproduced, stored in a retrieval system, or transmitted in any form or by any means, electronic, mechanical, photocopying, recording, or by any information storage and retrieval system, without the prior written consent of Entertainment Design Group, Inc. The user assumes all liability for any use of this document for any purpose other than that for which it was prepared. The user agrees to hold Entertainment Design Group, Inc. harmless for any and all claims, damages, losses, and expenses, including reasonable attorneys' fees, arising from the use of this document for any purpose other than that for which it was prepared. The user also agrees to hold Entertainment Design Group, Inc. harmless for any and all claims, damages, losses, and expenses, including reasonable attorneys' fees, arising from the use of this document for any purpose other than that for which it was prepared.

**INSTRUMENT KEY**

-  TMB Solaris Flare @ 1kw
-  FCME Outline 360 @ 450 w
-  Ayrton Diablo @ 550w
-  ETC Zoo
-  Protocus Radius
-  Philips Var-Lite VL3600 Profile @ 1.475kw
-  Philips Var-Lite VL4500 Beamwash @ 1.4kw
-  Robe iForte LTX @ 1.25kw
-  PRG GC Longthrow @ 1.5kw
-  DF-50 Hazer @ 44w
-  RauEX RE 5 Fan @ 2.5kw



**1 FIELD LEVEL LAYOUT**  
Scale: 3/32" = 1'-0"

VENUE  
SUPERDOME  
NEW ORLEANS, LA

SHOW  
**HALFTIME SHOW**

LOAD IN SHOWDAY SHOW  
TBD 02/28/25 2502

DESIGNER: AL CUBROON  
LEAD L.D.: BEN GREEN  
GAFFER: ALEN SISUL  
PROD. 1: E. MARCHINI  
PROD. 2: M. HUMPHREY  
LEAD TECH: R. MINNOTTE

VERSION  
01: PRELIMINARY 11-13  
02: FIELD TRUSS EDIT 11-24  
03: UPDATED 11-30  
04: UPDATED TRUSS 12-5  
05: UPDATED DUSTRO 12-28  
06: POWER LAYOUT 1-2  
07: CART UPDATE 1-8

PRINT ARCH E SHEET  
SCALE: AS NOTED

CONTENTS  
01: OVERVIEW  
02: PERIMETER TRUSS  
03: EAST 450 RAIL  
04: WEST 450 RAIL  
05: CENTER TRUSS  
06: FIELD LAYOUT  
07: GOALPOSTS  
08: CARTS  
09: LAMP POSTS  
10: N & S SECTION  
11: E & W SECTION  
12: FIELD POWER LAYOUT  
13: SERVICE LEVEL POWER

SHEET #  
**06**

PUBLISH DATE  
**01/06/2025**

FIELD LAYOUT