



FRONT VIEW

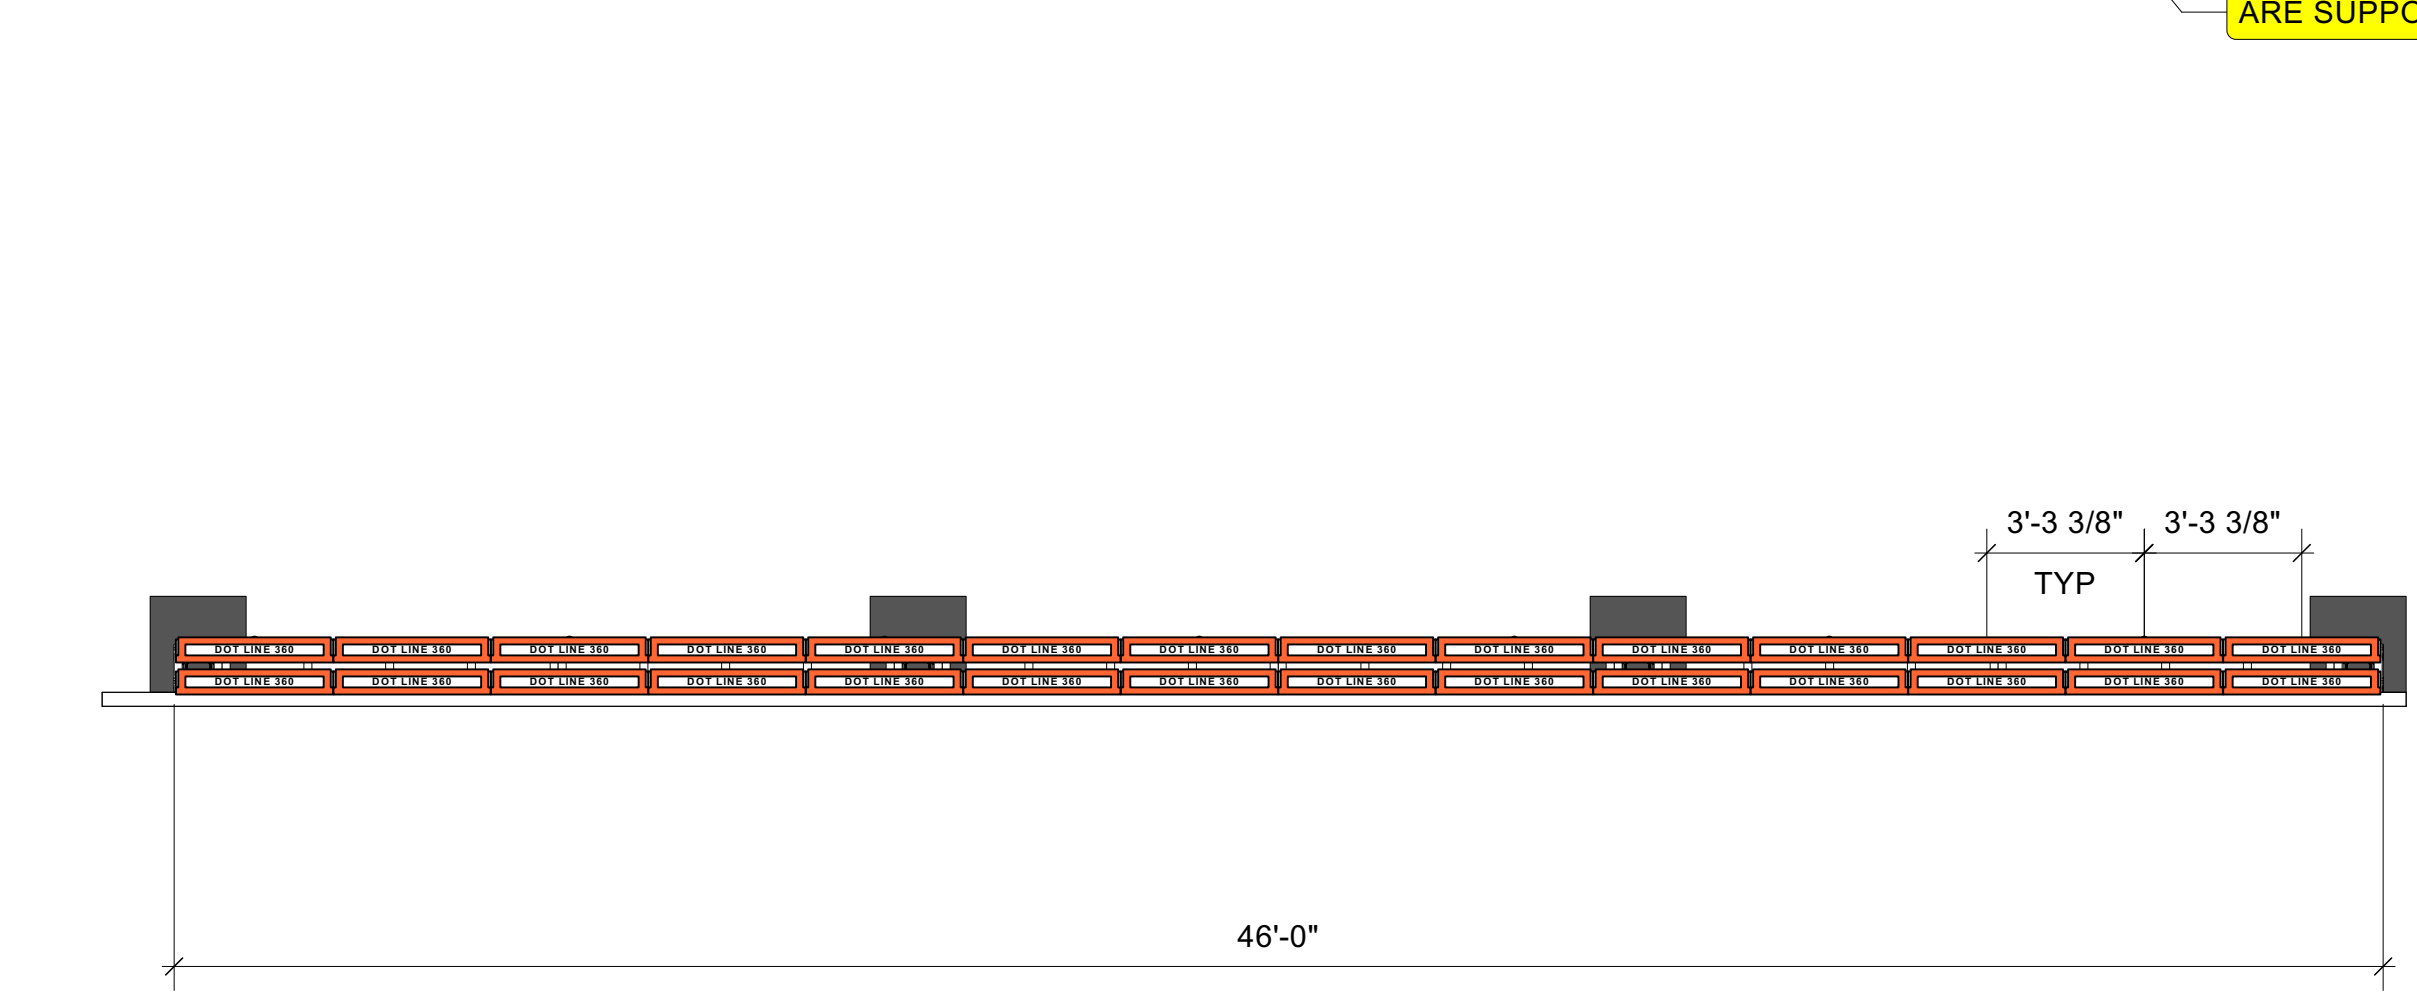

PLAN VIEW

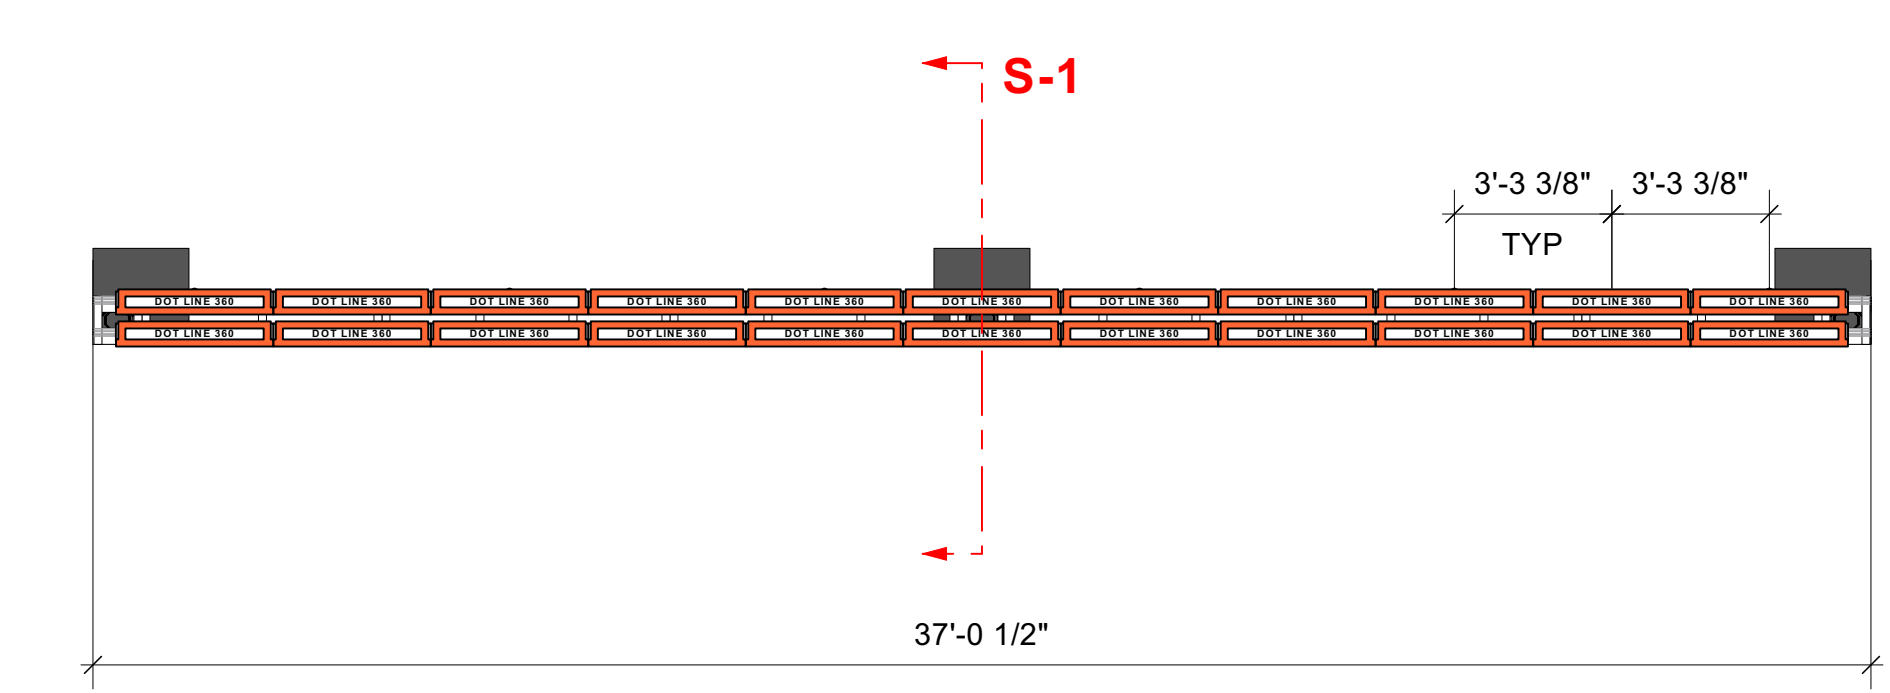

S-1 SECTION VIEW  
SCALE: 1/2"=1'-0"

LINE OF FIELD GRASS

NORTH

SOUTH

4'-0" GRAPHIC WALL IN FRONT OF GOALPOST

4'-0" GRAPHIC WALL IN FRONT OF GOALPOST


BOTH LINES OF FIXTURES ARE CENTER PIPED TO ALLOW FOR EXACT 1M SPACING

PIPE SUPPORTS FOR BACK LINE OF DOTLINES; 1ST LINE OF FIXTURES ARE SUPPORTED BY TRUSS


DOUBLE ROW OF DOTLINES AT DIFFERENT HEIGHTS

1 EAST FIELD GOALPOST  
Scale: 1/4" = 1'-0"


NOTE: GOALPOSTS DRAWN OUT OF POSITION; REFER TO FIELD LAYOUT FOR EXACT CONFIGURATION

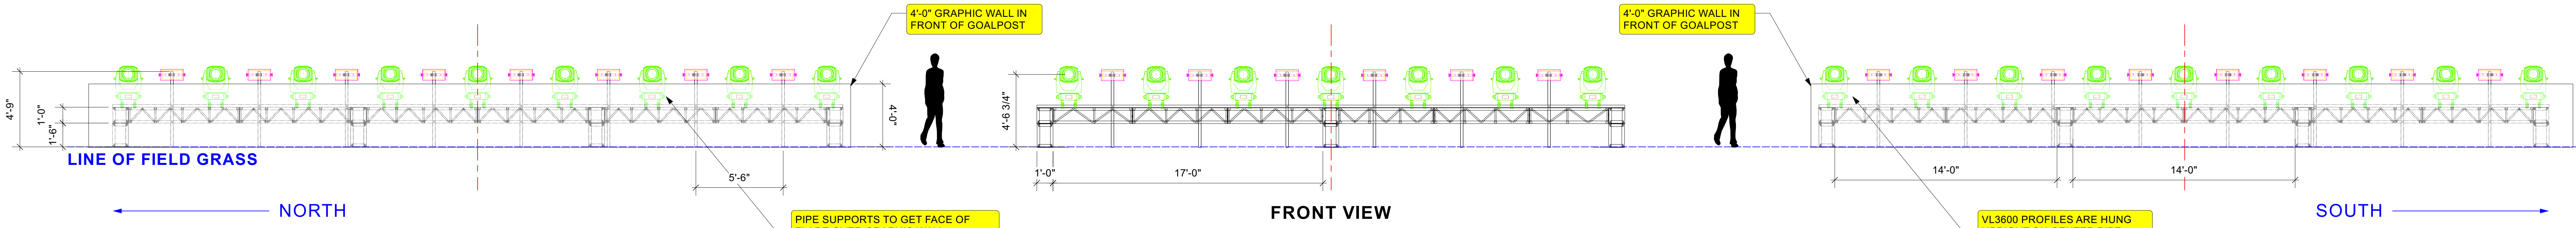

FRONT VIEW

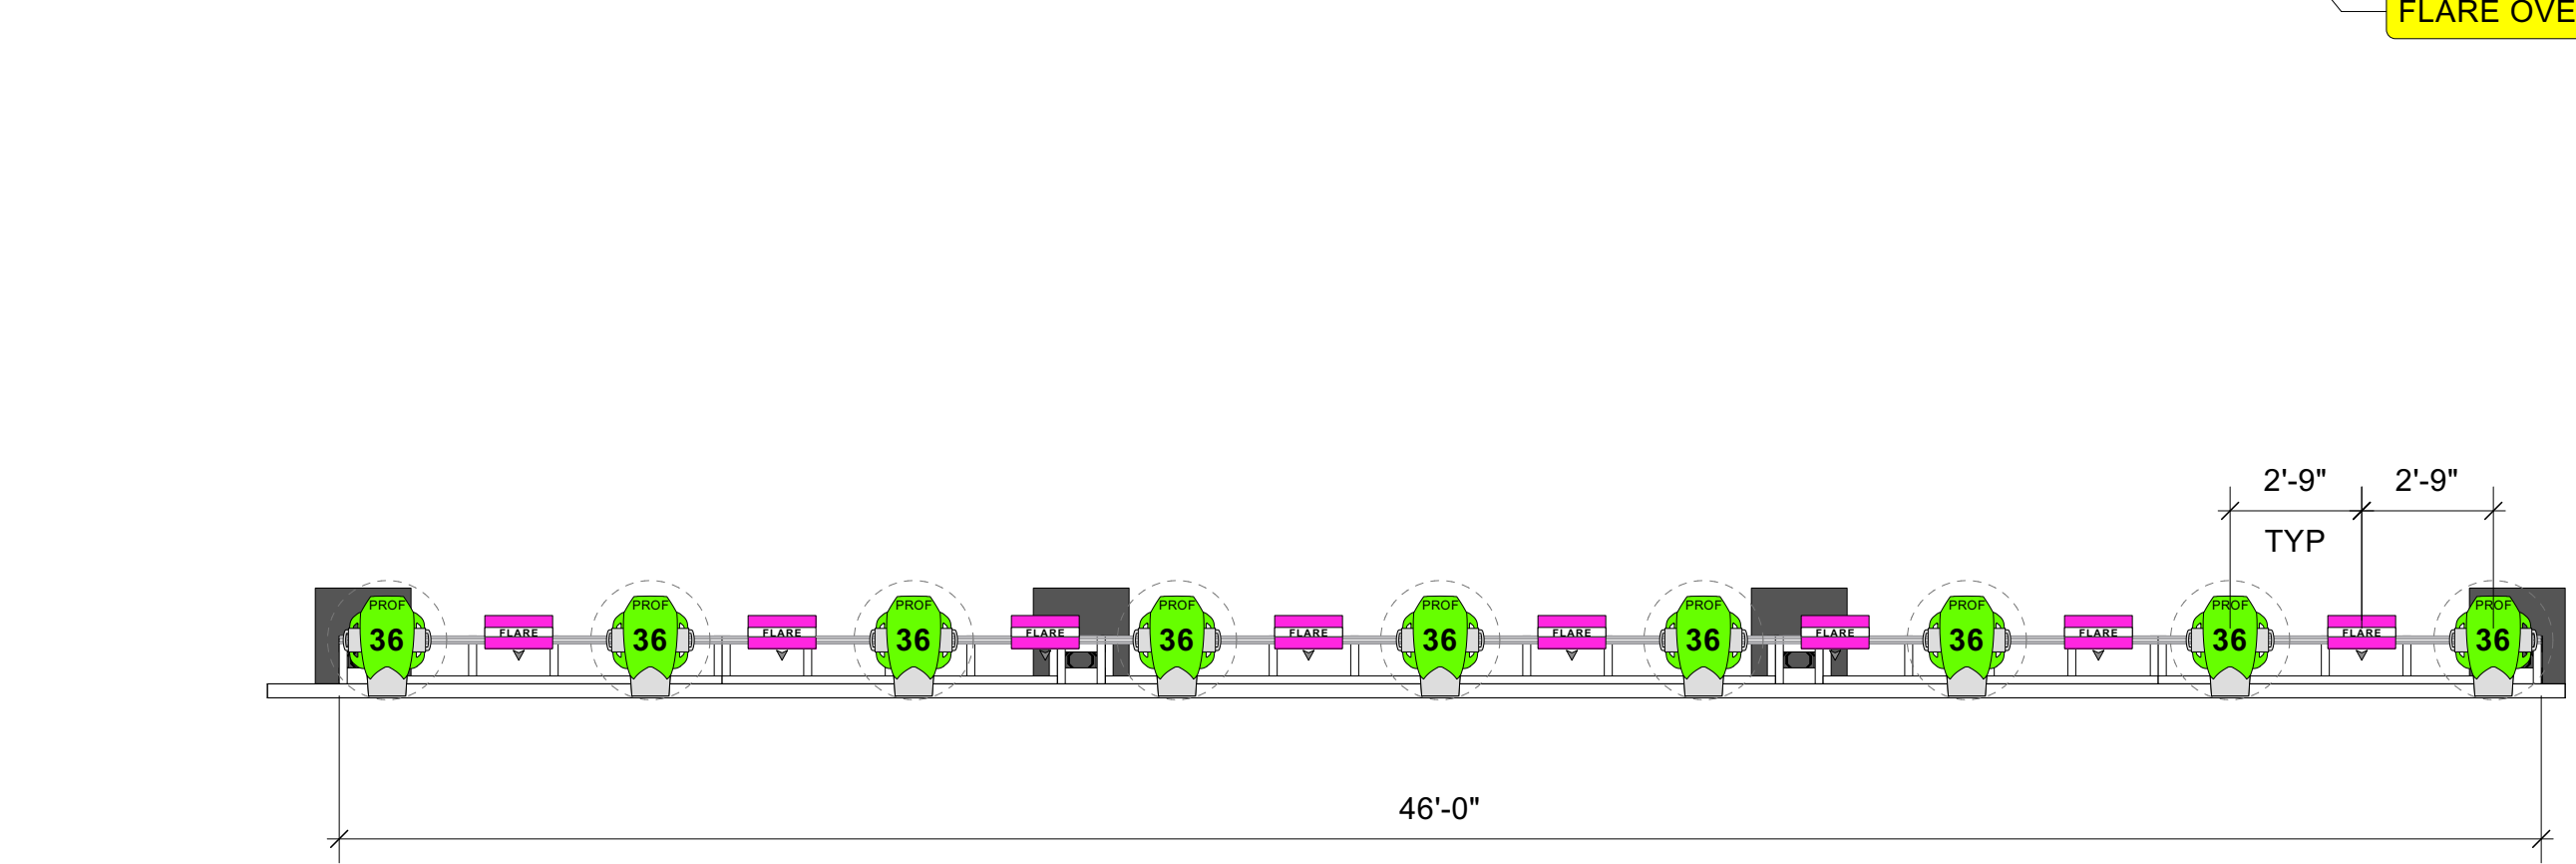

PLAN VIEW

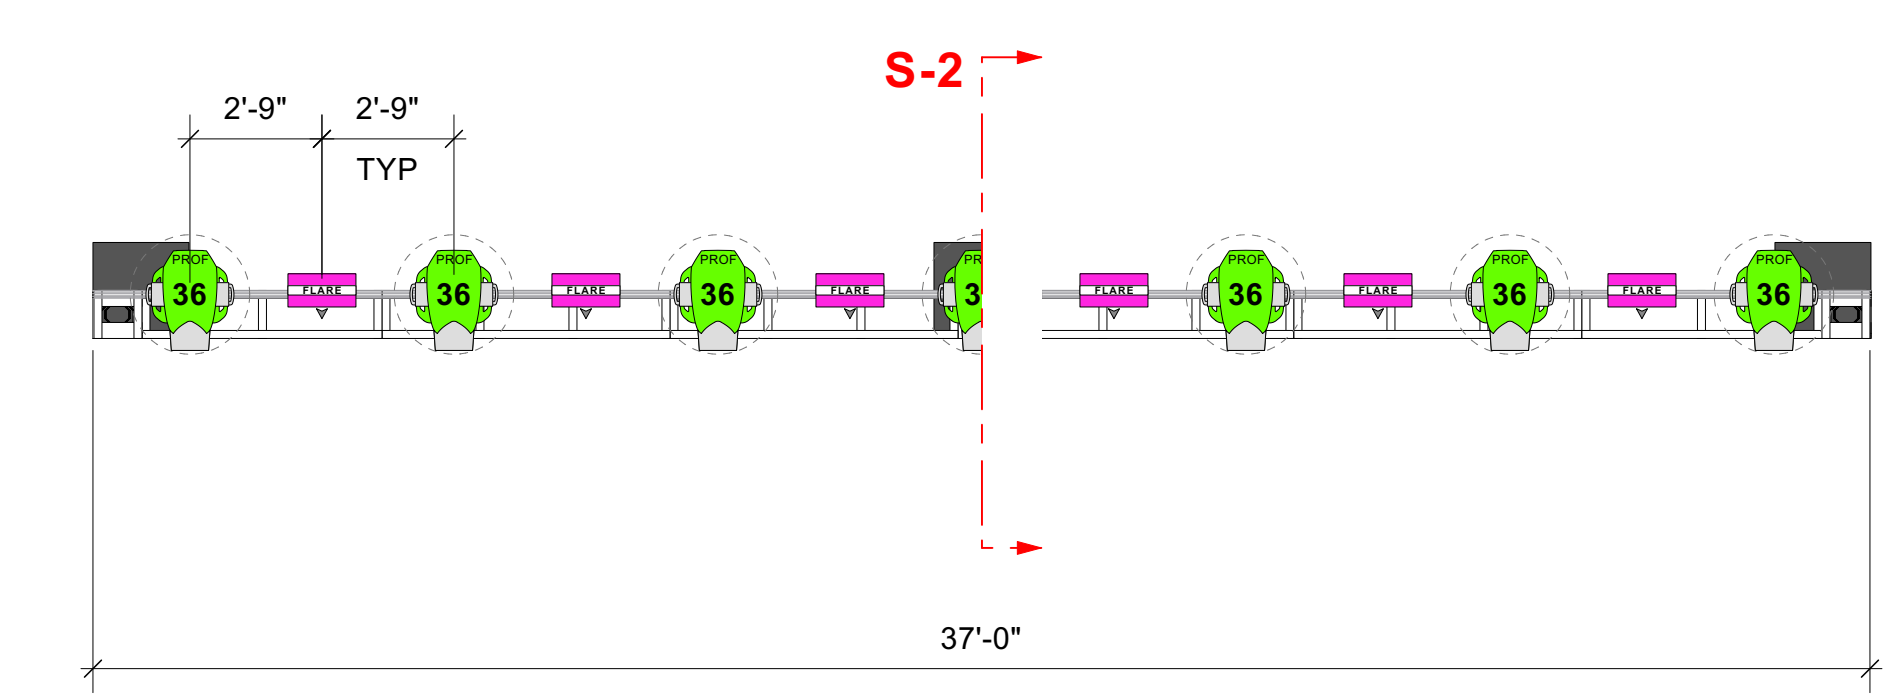

S-2 SECTION VIEW  
SCALE: 1/2"=1'-0"

LINE OF FIELD GRASS

NORTH

SOUTH

4'-0" GRAPHIC WALL IN FRONT OF GOALPOST

4'-0" GRAPHIC WALL IN FRONT OF GOALPOST

VL3600 PROFILES ARE HUNG UPRIGHT ON CENTER PIPE

PIPE SUPPORTS TO GET FACE OF FLARE OVER GRAPHIC WALL

PIPE SUPPORTS FLARES TO GET FACE OF FIXTURE ABOVE GRAPHIC WALL

VL3600 PROFILES HUNG UPRIGHT ON CENTER PIPE

2 WEST FIELD GOALPOST  
Scale: 1/4" = 1'-0"

NOTE: GOALPOSTS DRAWN OUT OF POSITION; REFER TO FIELD LAYOUT FOR EXACT CONFIGURATION

**ENTERTAINMENT DESIGN GROUP**  
Please recycle this paper.

**INSTRUMENT KEY**

- TMB Solaris Flare @ 15w
- ACME Outline 360 @ 450 w
- Ayrton Diablo @ 550w
- ETC Zoo
- Proteus Radius
- Philips Var-Lite VL3600 Profile @ 1.475kw
- Philips Var-Lite VL4500 Beamwash @ 1.4kw
- Robe iForte LTX @ 1.25kw
- PRG GC Longthrow @ 1.5kw
- DF-50 Hazer @ 440w
- RealEFX RE 5 Fan @ 2.8kw

**REVISION**

NO.	DATE	DESCRIPTION
01	PRELIMINARY 11-13	
02	FIELD TRUSS EDIT 11-24	
03	UPDATED 11-30	
04	UPDATED TRUSS 12-5	
05	UPDATED DISTO 12-26	
06	POWER LAYOUT 1-2	
07	CART UPDATE 1-8	

**PRINT ARCH E SHEET**

DESIGNED BY: J. BEHM  
SCALE: AS NOTED

**CONTENTS**

01. OVERVIEW
02. PERIMETER TRUSS
03. EAST 450 RAIL
04. WEST 450 RAIL
05. CENTER TRUSS
06. FIELD LAYOUT
07. GOALPOSTS
08. CARTS
09. LAMP POSTS
10. N & S SECTION
11. E & W SECTION
12. FIELD POWER LAYOUT
13. SERVICE LEVEL POWER

**SHEET #**  
07

**PUBLISH DATE**  
01/06/2025

**GOALPOSTS**